


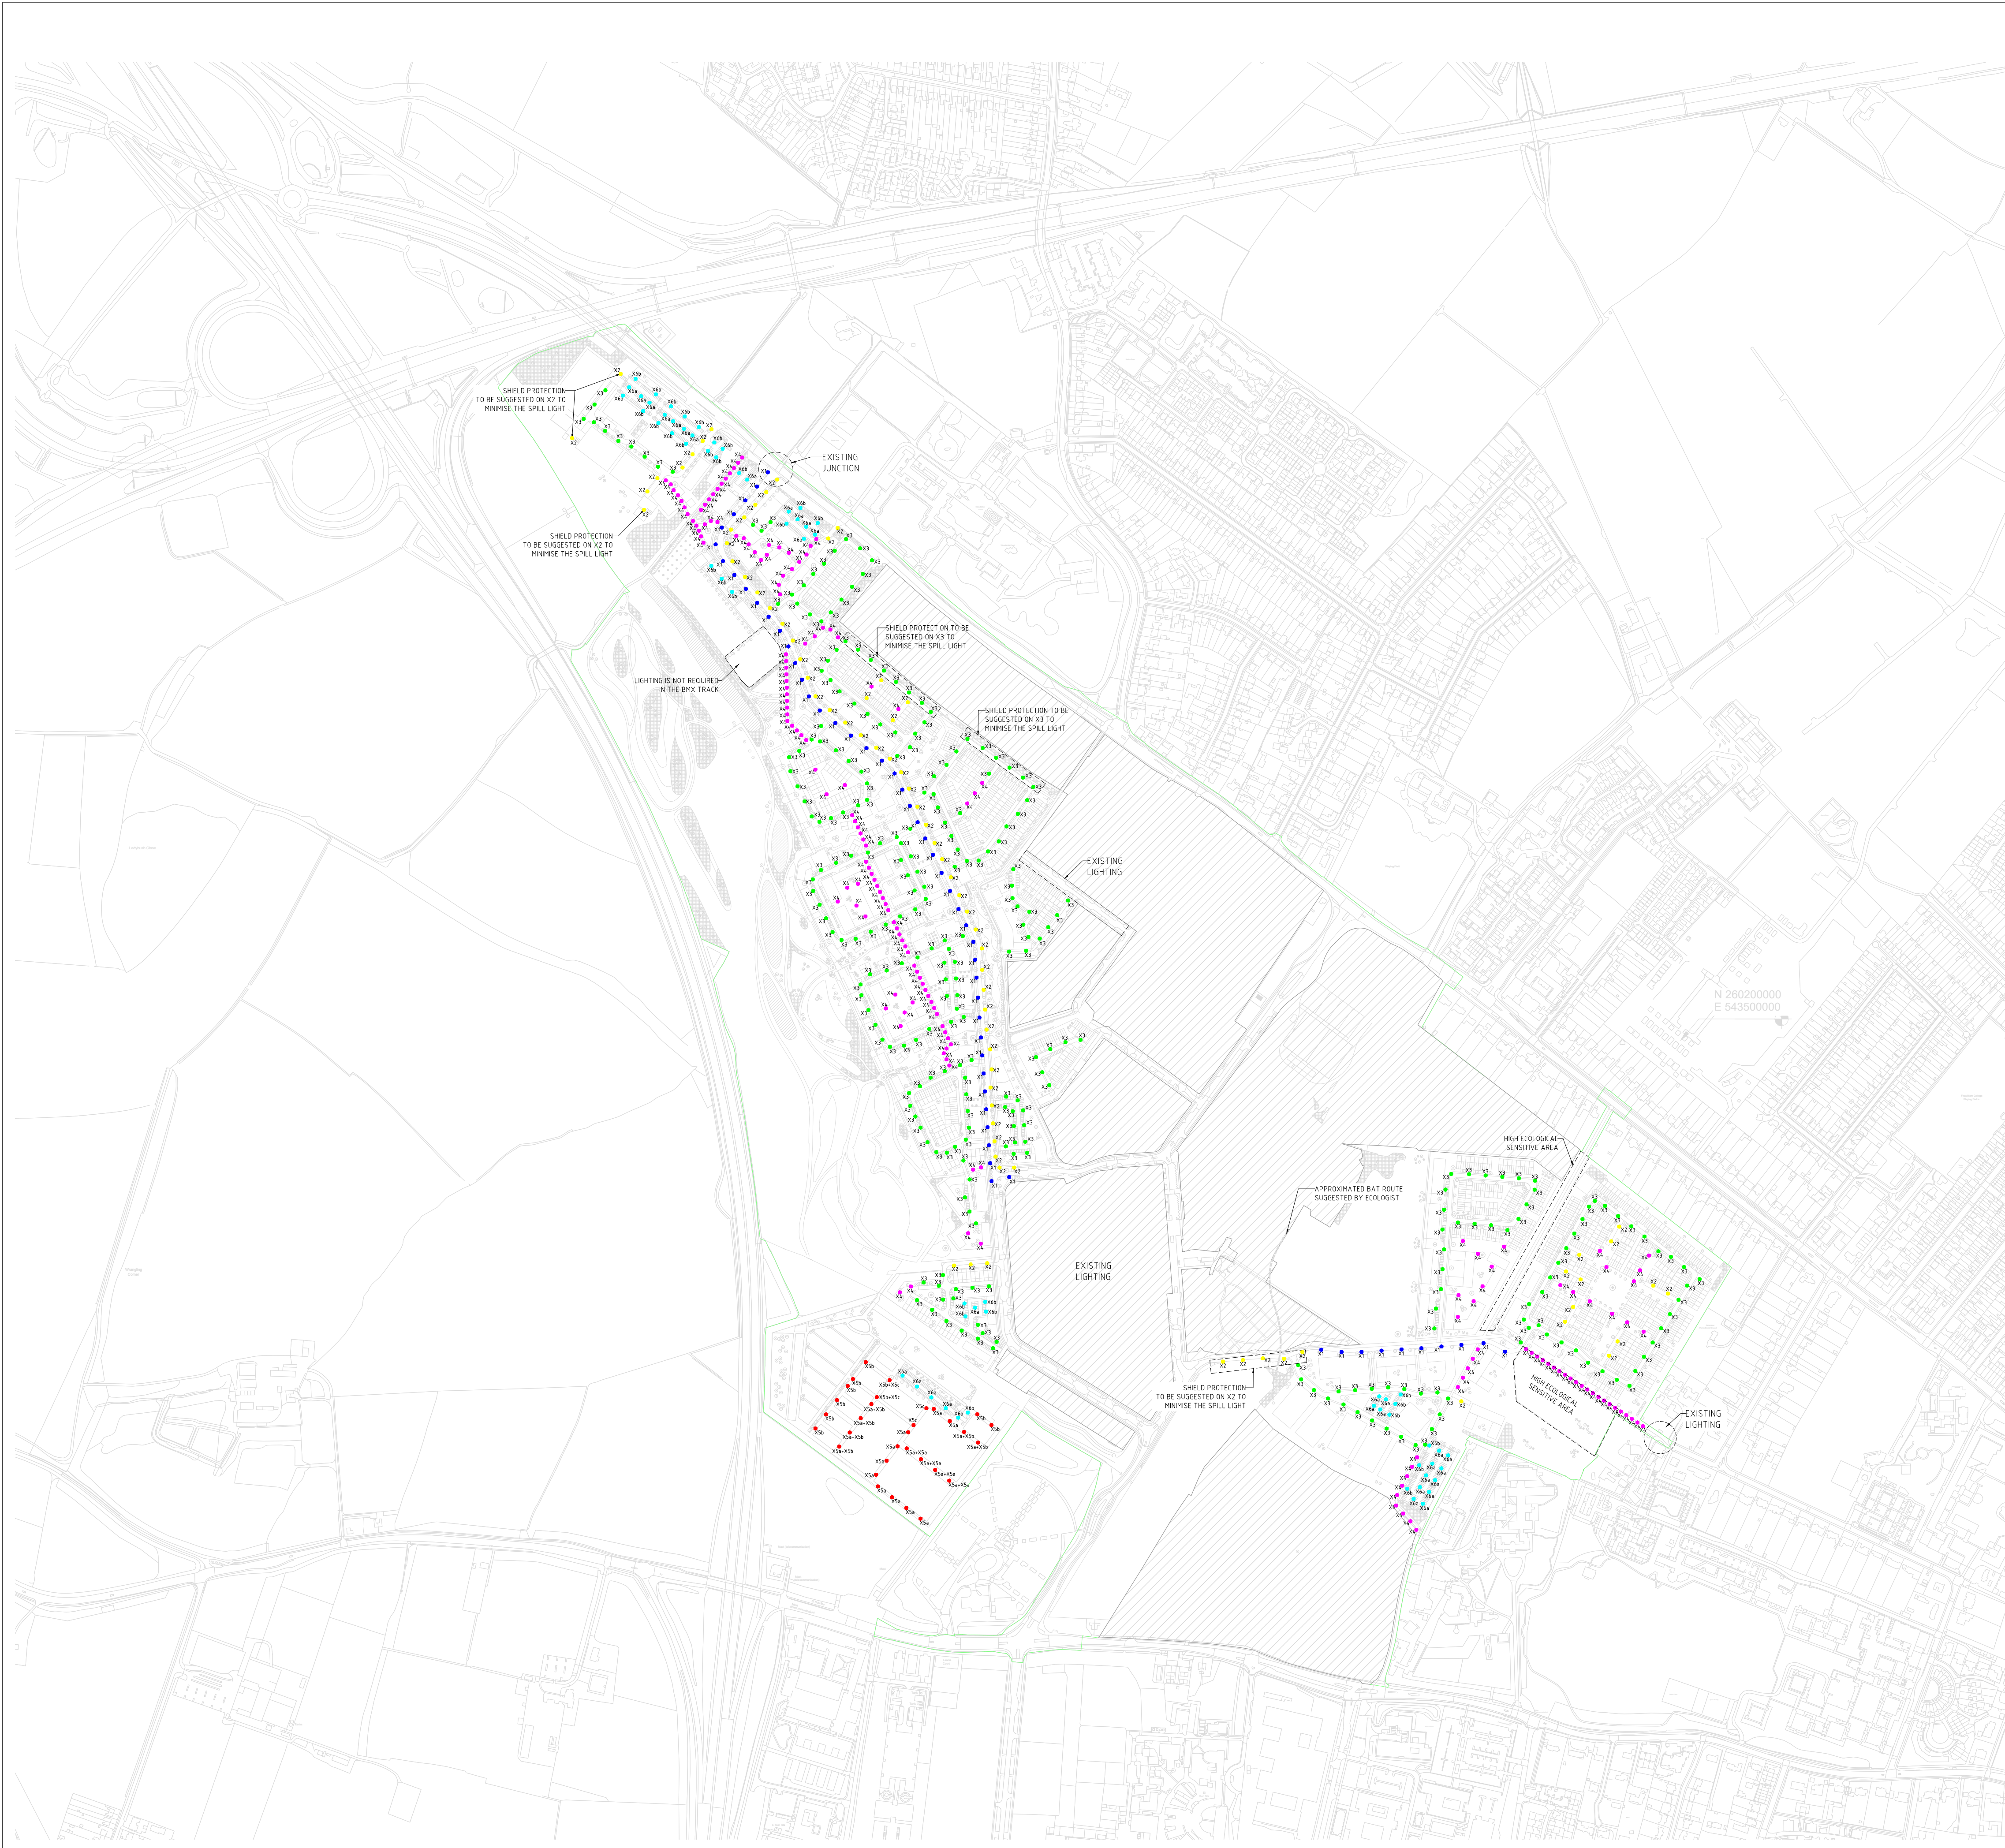

BDP SHALL HAVE NO RESPONSIBILITY FOR ANY USE MADE OF THIS DOCUMENT OTHER THAN FOR THAT WHICH IT WAS PREPARED AND ISSUED.
ALL DIMENSIONS SHOULD BE CHECKED ON SITE.
DO NOT SCALE FROM THIS DRAWING.
ANY DRAWING ERRORS OR OVERSIGHTS SHOULD BE BROUGHT TO THE ATTENTION OF BUILDING DESIGN PARTNERSHIP AT THE ADDRESS SHOWN BELOW

NOTES

- LIGHTING LAYOUTS SHALL BE READ IN CONJUNCTION WITH THE FOLLOWING DOCUMENTS: BDP LIGHTING CONCEPT PROPOSAL(NWC-MP2024-BDP-XX-RP-00001)

LEGEND

- X1
TOTAL COLUMNS NUMBER: 56
- X2
TOTAL COLUMNS NUMBER: 79
- X3
TOTAL COLUMNS NUMBER: 293
- X4
TOTAL COLUMNS NUMBER: 180
- X5a/X5b/X5c
TOTAL COLUMNS NUMBER: 32
- X6a
TOTAL COLUMNS NUMBER: 31
- X6b
TOTAL COLUMNS NUMBER: 34
- SITE BOUNDARY

P07 - FINAL DOCUMENT	KL	CB	28.07.2025
P06 - FINAL DRAFT FOR LEGAL REVIEW	KL	CB	28.07.2025
P05 - PLANNING APPLICATION FINAL DRAFT	KL	CB	30.06.2025
P04 - PLANNING APPLICATION DRAFT	KL	CB	23.05.2025
WIP - FOR INFORMATION ONLY	KL	CB	30.04.2025
P03	KL	CB	24.03.2025
P02	KL	CB	14.03.2025
P01	KL	CB	14.02.2025

REVISION / DESCRIPTION	DRAWN	AUTHORED	DATE
------------------------	-------	----------	------



BDP.

16 Brewhouse Yard
Clerkenwell
London EC1V 4LJ
T +44 (0)20 7812 8000
www.bdp.com

PROJECT
**NORTH WEST CAMBRIDGE
MASTERPLAN FUTURE PHASES**

DRAWING TITLE PROPOSED EXTERIOR LIGHTING PLAN - ILLUSTRATIVE SCHEME	SCALE 1:5000
JOB NUMBER P3004544	DATE 18.08.2025

DRAWING NO. NWC-MP2024-BDP-SW-DR-00001	REVISION P07
--	------------------------